

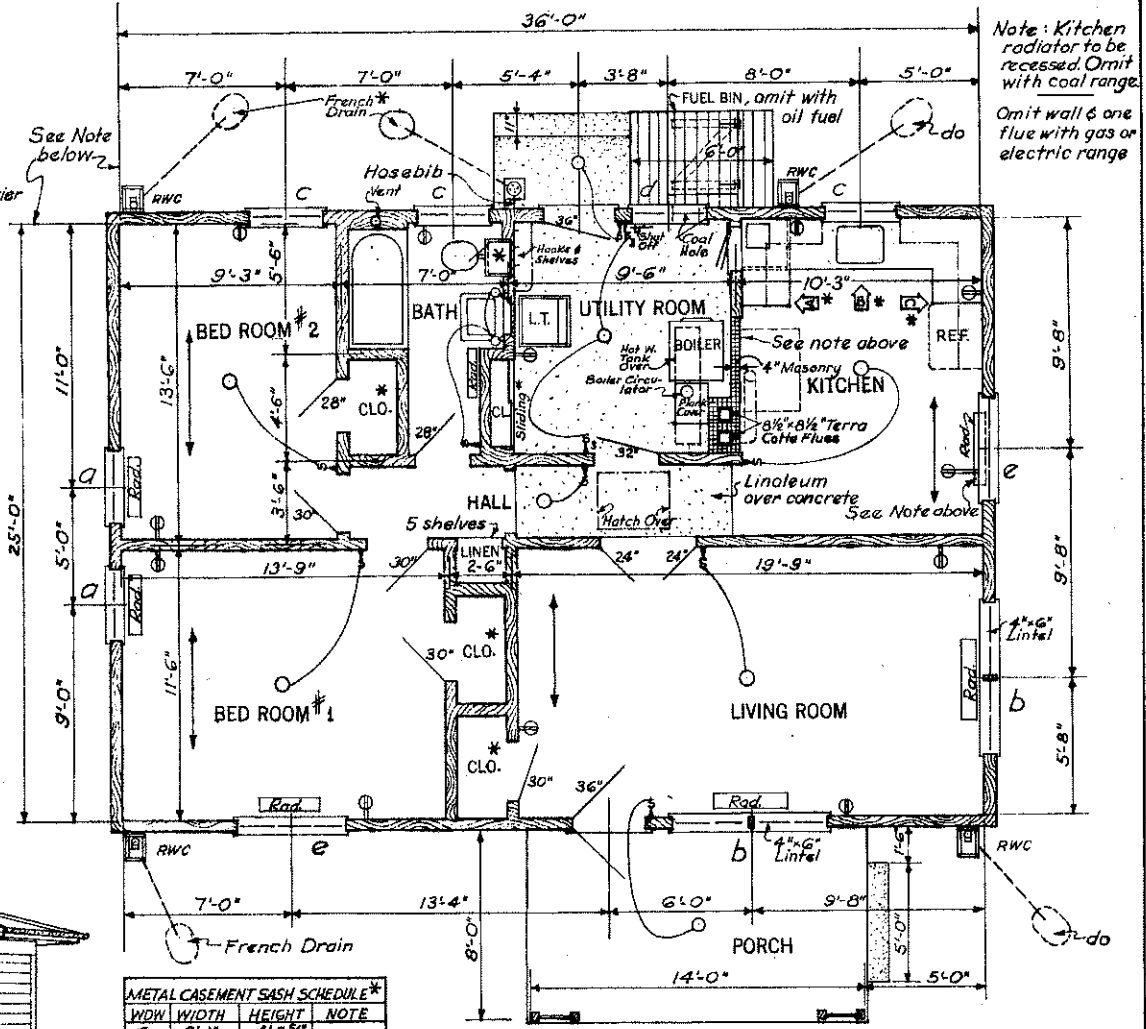


Where masonry is substituted, replace sheet 3 with EX. 7031

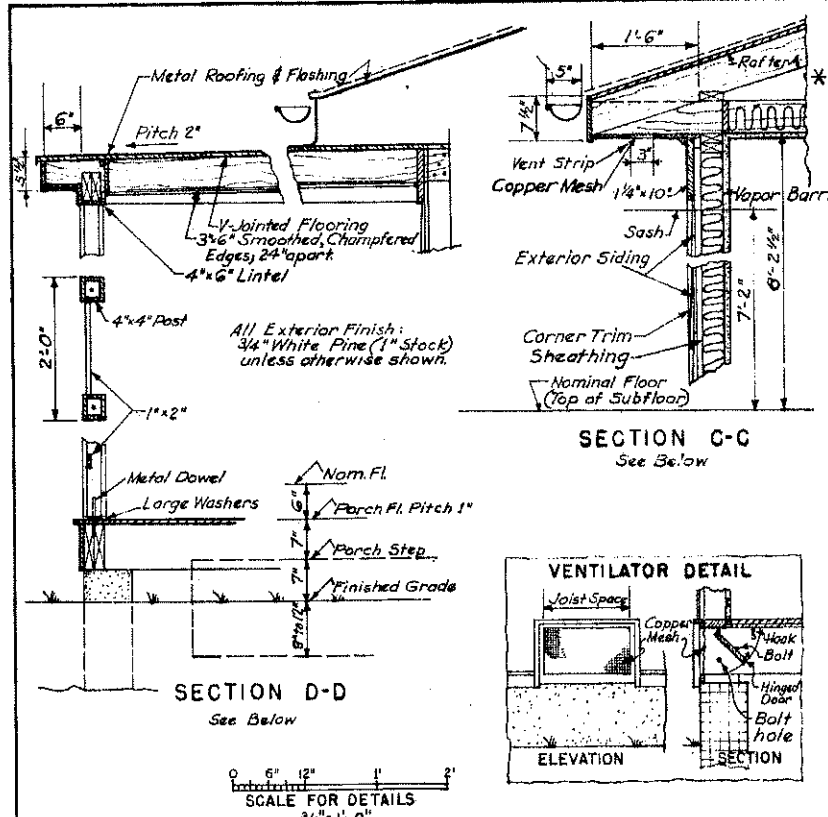

Note: Kitchen radiator to be recessed. Omit with coal range. Omit wall & one flue with gas or electric range.

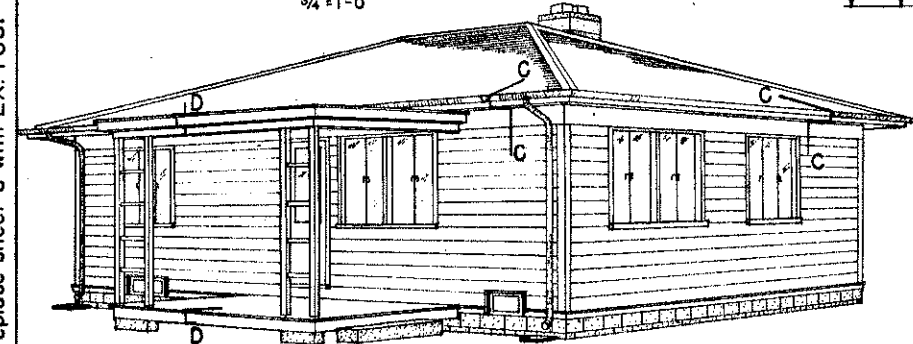

METAL CASEMENT SASH SCHEDULE*			
WDW	WIDTH	HEIGHT	NOTE
a	3'-1"	4'-2 1/2"	Doubled
b	"	"	
c	"	3'-2 3/8"	Doubled
d	"	2'-2"	
e	4'-5 1/8"	4'-2 3/8"	Cellar
f	2'-9"	1'-10"	

All to have Screens supplied by manufacturer of sash.


FLOOR PLAN SCALE 1/4" = 1'-0"

For Masonry Walls retain same dimensions for inside face of Masonry.

→ Ceiling Joists all 2"x6" Spaced every 16"

↔ Direction Rafter


* SEE DETAILS, Sheets 3, 4 & elsewhere

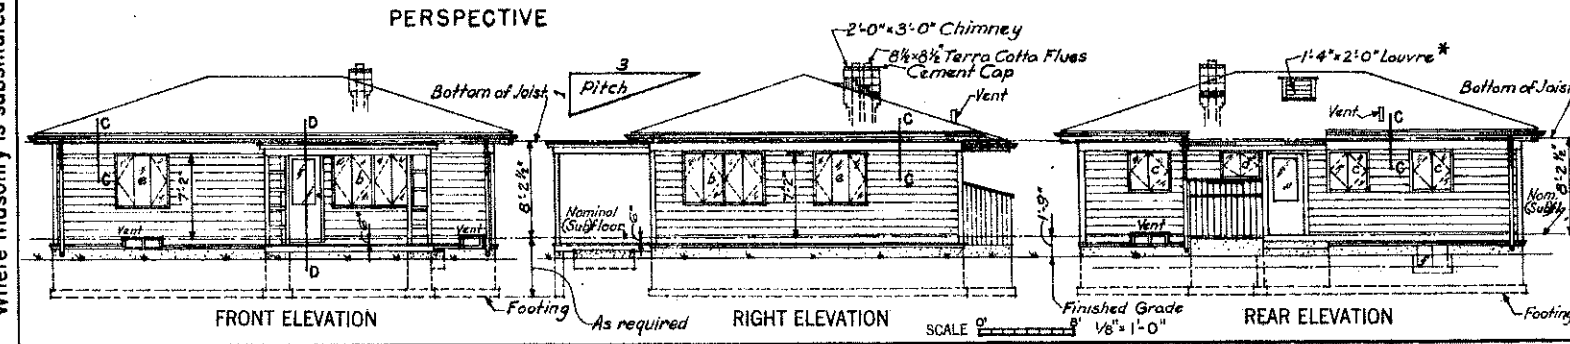

COOPERATIVE EXTENSION WORK IN AGRICULTURE AND HOME ECONOMICS
STATE OF NORTH DAKOTA
NORTH DAKOTA AGRICULTURAL COLLEGE AND
UNITED STATES DEPARTMENT OF AGRICULTURE COOPERATING


FARMHOUSE PLAN

USDA '47 EX. 7012 SHEET 1 OF 4


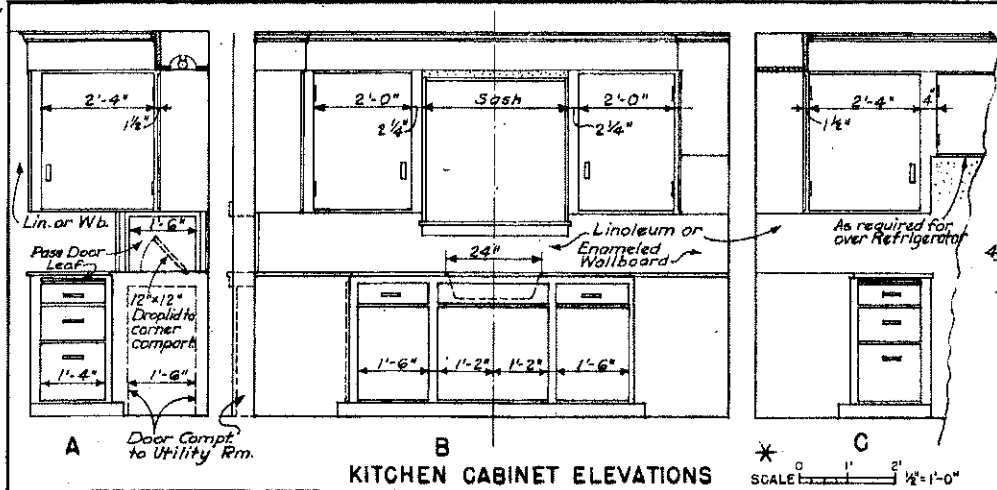


PLUMBING FIXTURE SCHEDULE

Lav.	22x18" Mixing single faucet
Tub	30x60" Exposed shower
W.C.	29" Low tank
Sink	18x24" Mixing swing faucet
L. Trays	24x24"
Med. Cab.	18x24" Wired for electricity

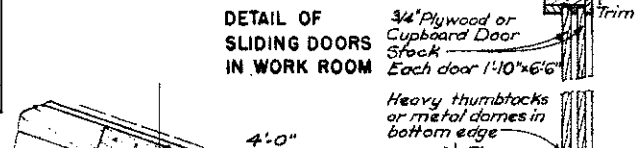


SECTION OF PORCH ROOF, COAL BIN & WORK ROOM FLOOR

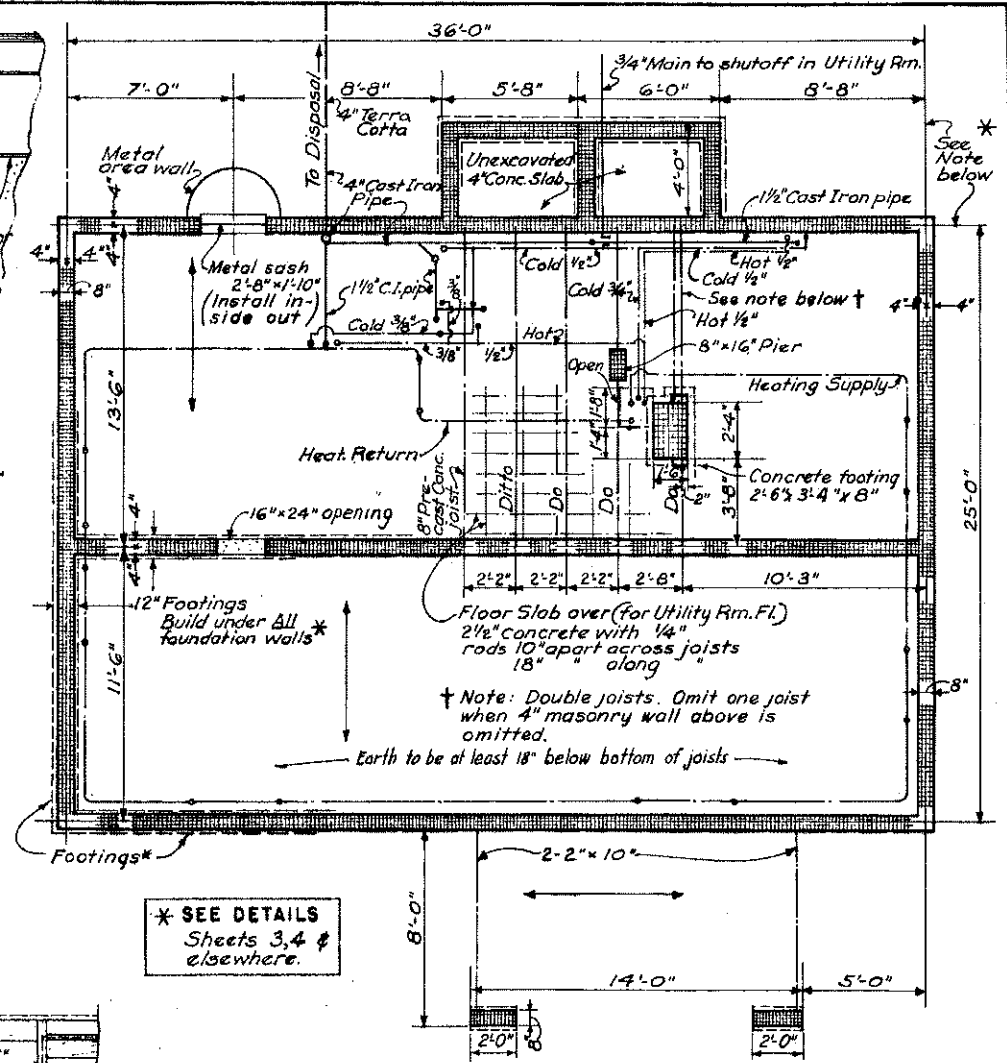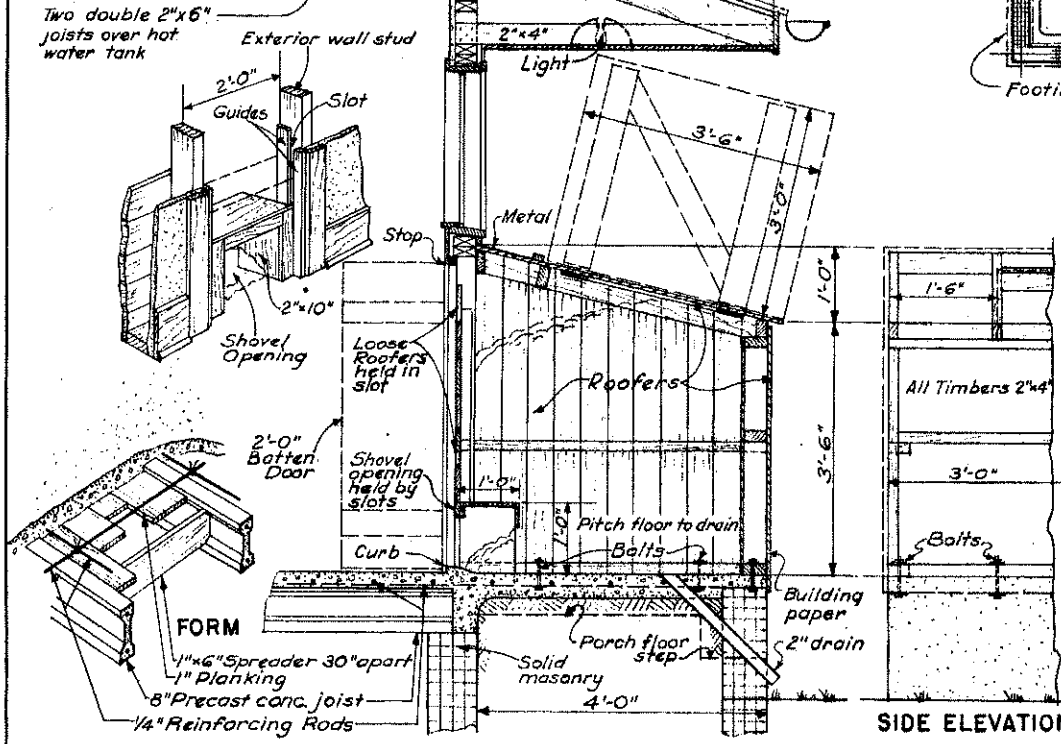

NOTE: For masonry superstructure, overall dimensions for exterior foundation walls read to inside face of masonry.

Direction: Floor joists, all 2" x 8" spaced every 16" apart except as noted.






HEATING is to be Hot Water or Steam, pump circulation, through single pipe shown above to radiators of adequate size located where shown on Floor Plan.

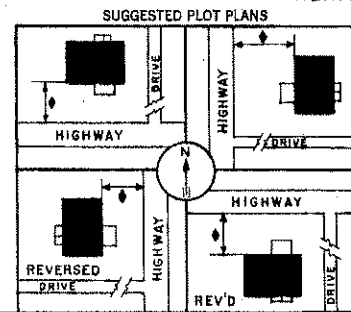

COOPERATIVE EXTENSION WORK IN AGRICULTURE AND HOME ECONOMICS
STATE OF NORTH DAKOTA
NORTH DAKOTA AGRICULTURAL COLLEGE
AND
UNITED STATES DEPARTMENT OF AGRICULTURE COOPERATING

FARMHOUSE PLAN

USDA '47 EX. 7012 SHEET 2 OF 4

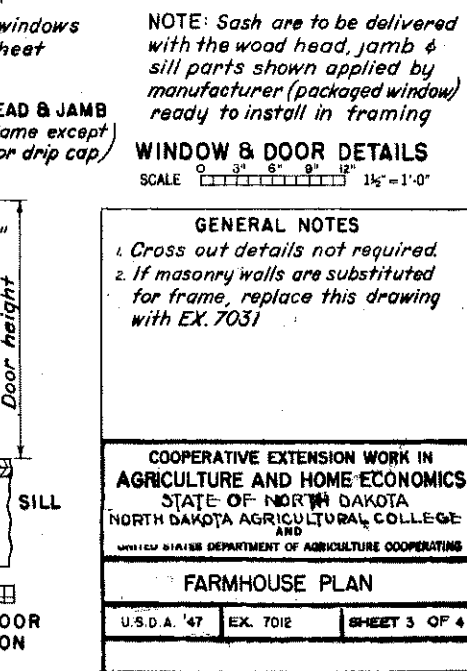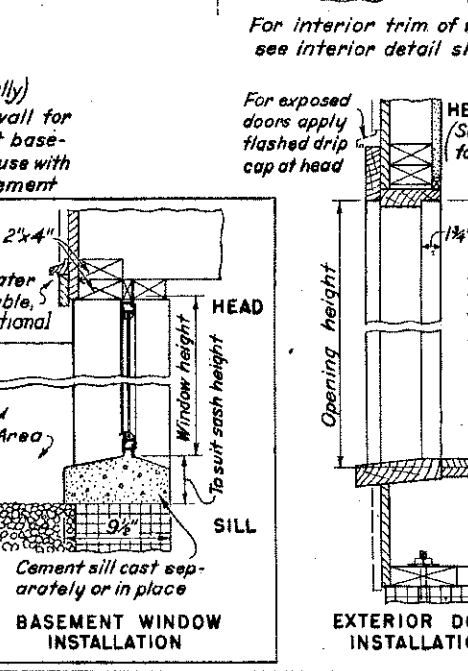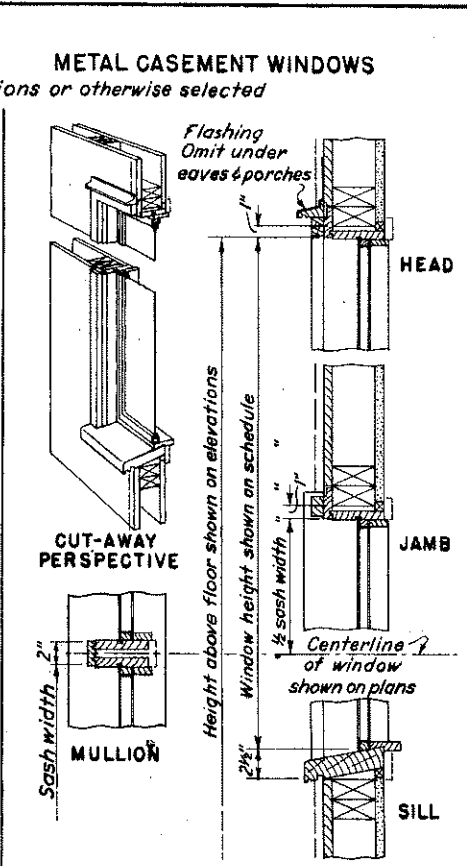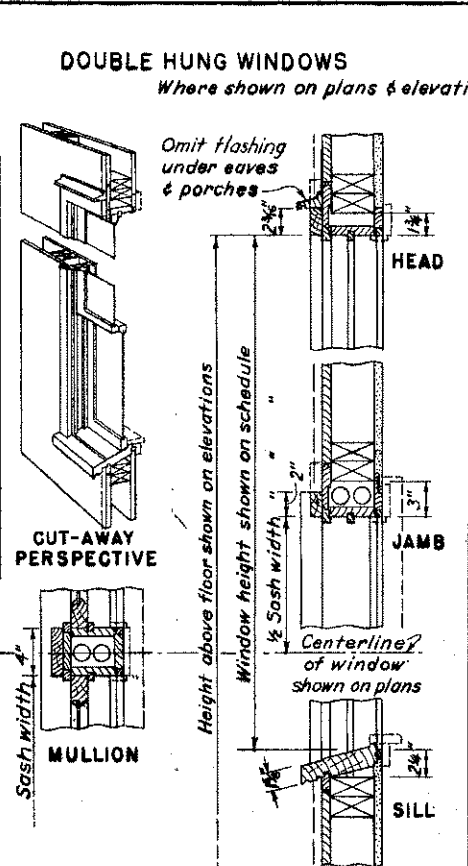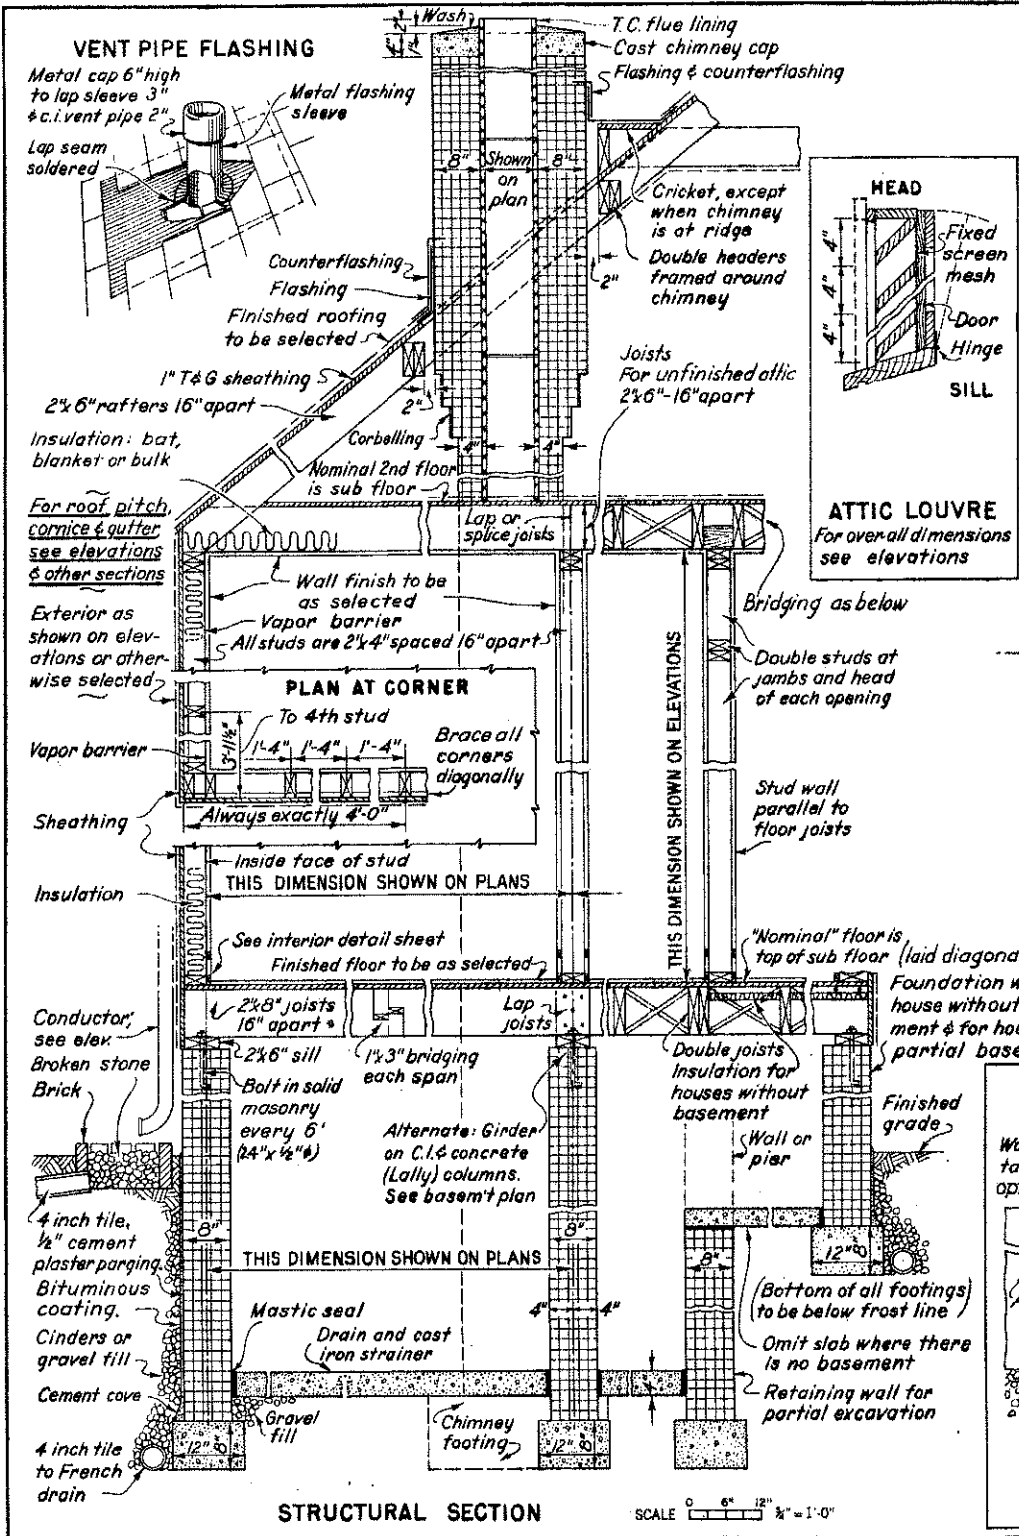

NOTE: Sash are to be delivered with the wood head, jamb & sill parts shown applied by manufacturer (packaged window) ready to install in framing
WINDOW & DOOR DETAILS
 SCALE 0 3" 6" 9" 12" 1 1/2" - 1'-0"

GENERAL NOTES
 1. Cross out details not required.
 2. If masonry walls are substituted for frame, replace this drawing with EX. 7031
COOPERATIVE EXTENSION WORK IN AGRICULTURE AND HOME ECONOMICS
 STATE OF NORTH DAKOTA
 NORTH DAKOTA AGRICULTURAL COLLEGE AND
 NORTH DAKOTA DEPARTMENT OF AGRICULTURE COOPERATING
FARMHOUSE PLAN
 U.S.D.A. '47 EX. 7012 SHEET 3 OF 4

STRUCTURAL SECTION SCALE 0 6" 12" 1/2" - 1'-0"

SYMBOLS USED ON DRAWINGS IN THIS SET

STRUCTURAL
 --- Work above plan or this (near) side of Section.
 --- below " other (far) "
 * SEE DETAILS for more directions on detail sheets or on plan sheets.
 Dada Ditto: Same as shown directly above or at left.
PLAN
 [Symbol] Optional Masonry, Brick, Block, Tile, Concrete.
 [Symbol] Frame Walls & Partitions.
 [Symbol] Metal Casements, [Symbol] Double Hung Windows.
SECTION
 [Symbol] Wood, [Symbol] Masonry, [Symbol] Concrete, [Symbol] Earth.
 [Symbol] Insulation, T.C.F.L. Terra Cotta Flue Lining, [Symbol] Center Line.
ELECTRICAL
 [Symbol] Ceiling Light, [Symbol] Convenience Outlet, [Symbol] Switch, [Symbol] 3 Ways.
HEATING
 [Symbol] Warm Air Register, [Symbol] Air Return, Wall, [Symbol] Floor, [Symbol] Riser Duct.

